

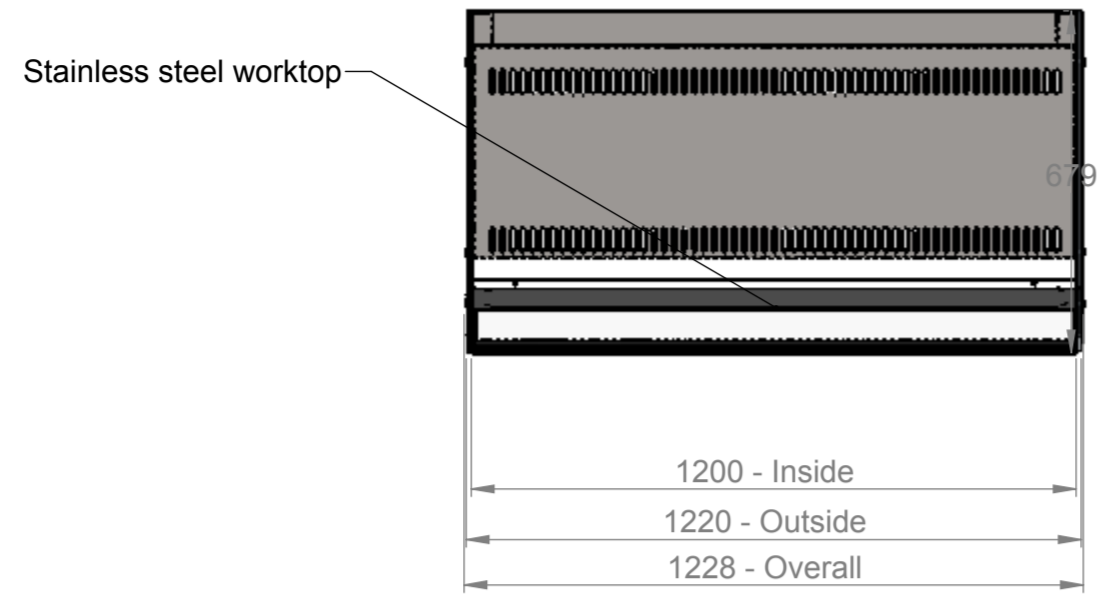



3rd Angle Projection.   
 This drawing and the information properties contained there on is the property of Counterline Ltd and must not be copied or issued to a third party without the prior consent of Counterline Ltd.

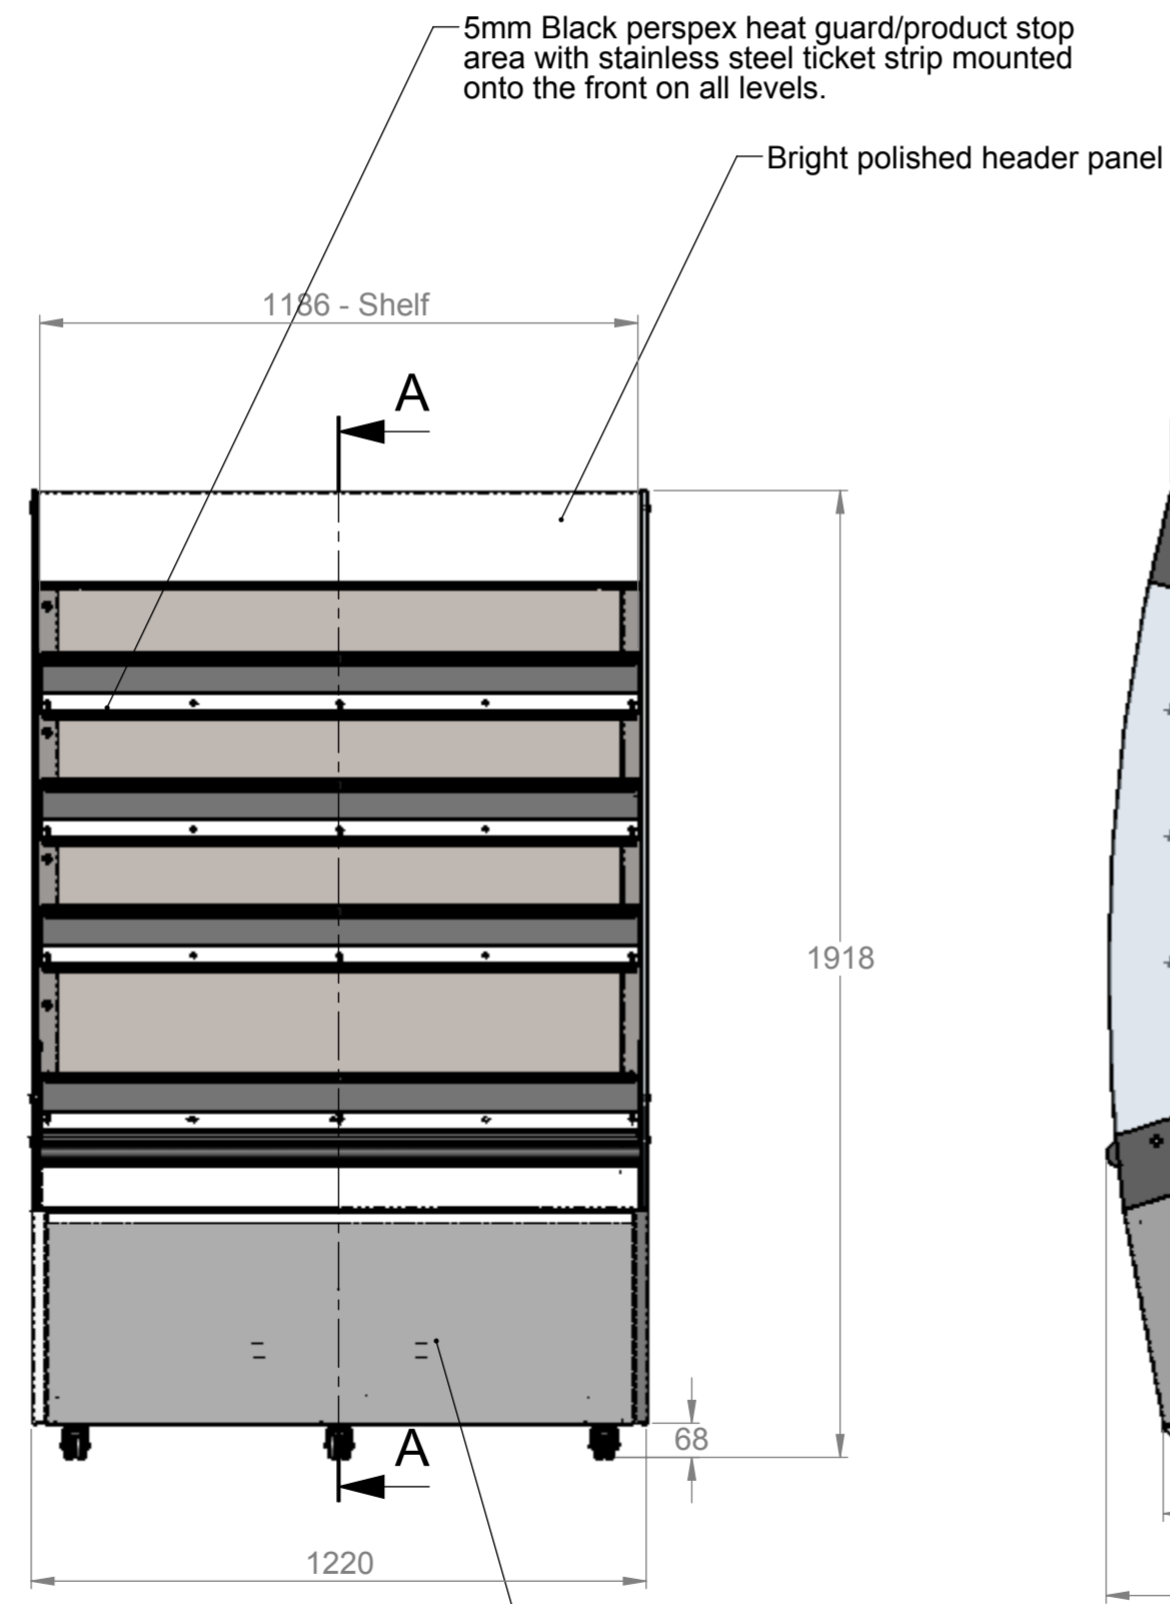

Plan

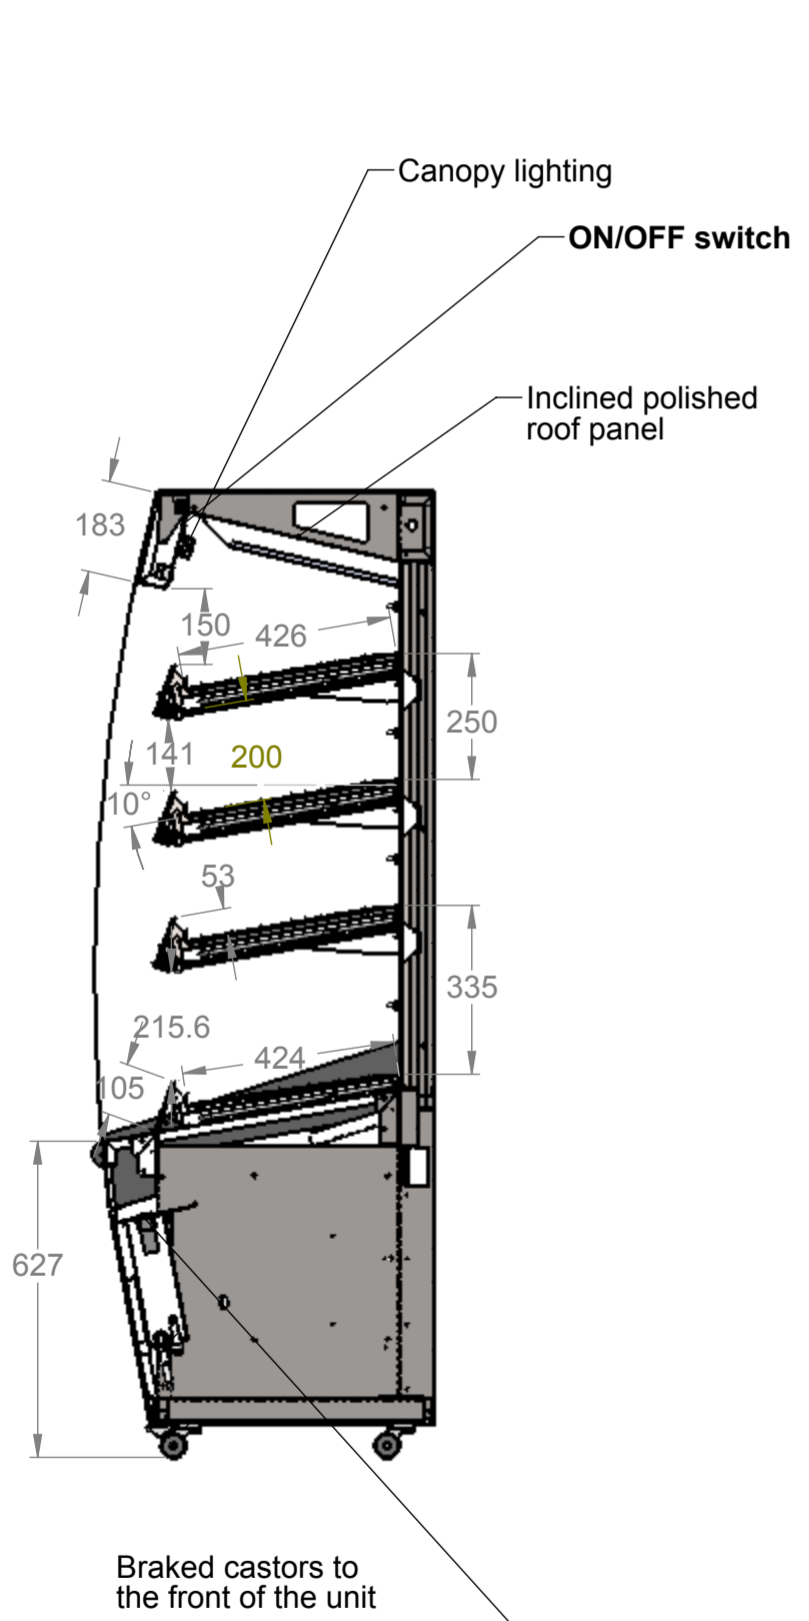


Front elevation

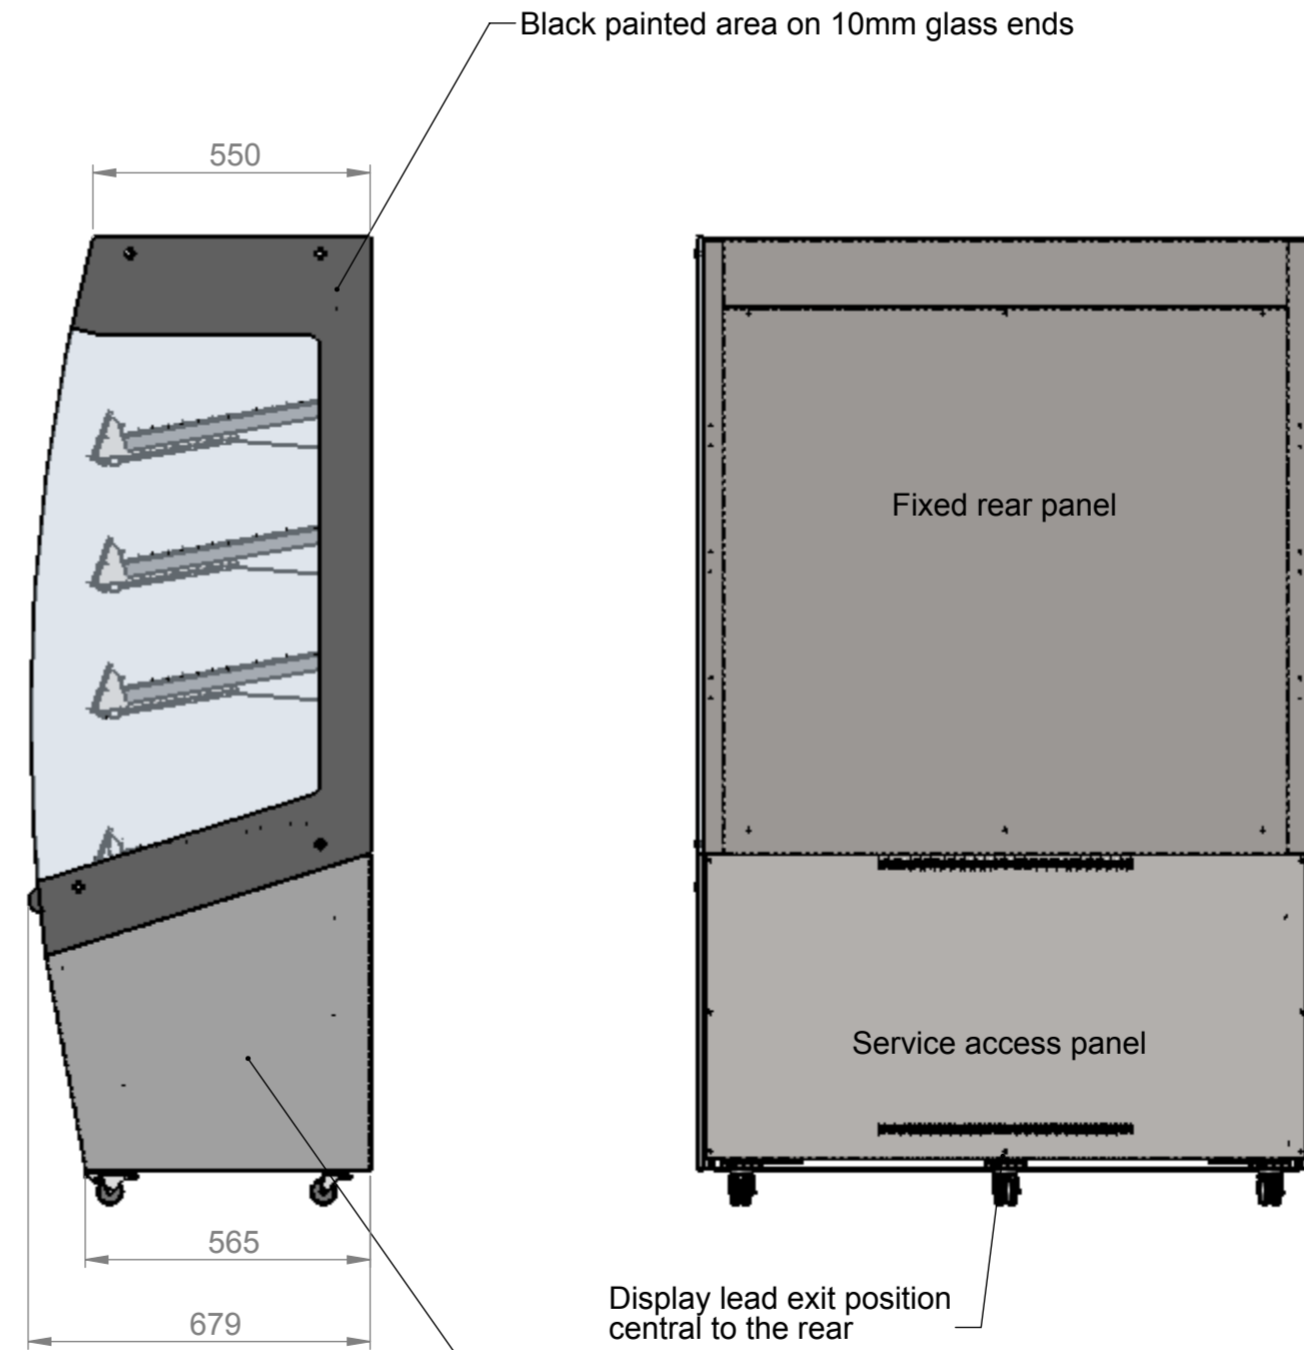

End elevation

Rear elevation

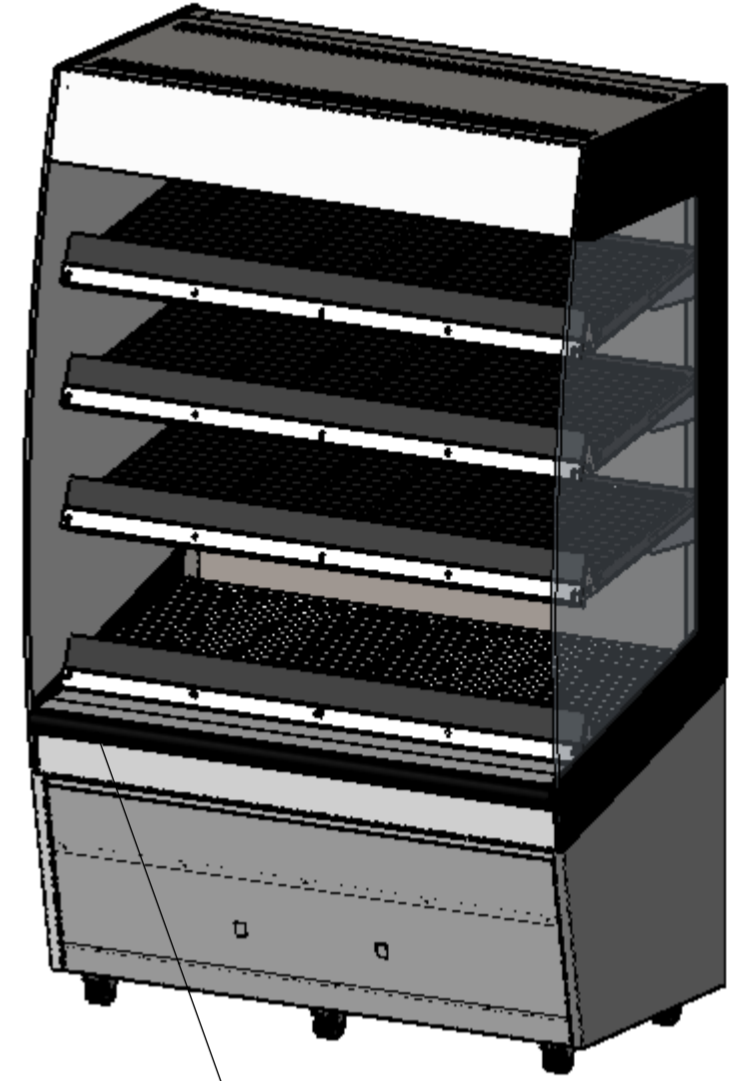


Isometric

50mm Black bumper rail

ELECTRICAL SUPPLY - 20 Amp 230 Volt (4Kw)

Stock Code - EHF1200

| Issue   | Date           | Description      |
|---|----------------|------------------|
| <br>Randles Rd, Knowsley Business Park, Merseyside L34 9HZ.<br>Tel: 0151 548 2211 Fax: 0151 549 2179 |                |                  |
| Title: Heated Multi Level 1200 Display  |                |                  |
| Drg No :  | Issue:         | Date: 12/08/2014 |
| 12-126--A   |                | Scale: 1:15 @ A2 |
|   |                | Chk'd:           |
| Drn by: G Burgess   | All dims in MM | Date:            |